


LEGEND - CEILING

- L-1** RECESSED LED LINEAR STRIP LIGHTS WITH SCENE SETTINGS FOR AV. LIGHTS TO MATCH LIFT LOBBY
- L-2** LINEAR SLOT LIGHT ON VERTICAL FACE OF BULKHEAD
- L-3** PENTANT LIGHT
- (2700)** ALL EXISTING RAISED FLOOR TO CEILING HEIGHT 2700mm AFFL. UNLESS INDICATED DIFFERENTLY
- WiFi** WI-FI LOCATIONS
- REMOVE SUSPENDED TILES & REPLACE WITH NEW PLASTERBOARD CEILING
- RETAIN EXISTING CEILING & MAKE GOOD WHERE DEMOLITION
- RE-USE EXISTING TILES FROM RECEPTION AREA
- ACOUSTIC FABRIC TILES FLUSH WITH CEILING
- EXISTING PLASTERBOARD
- NEW PLASTERBOARD BULKHEAD
- MECHANICAL**
- NEW GRILLE
- ACCESS PANELS 600x600mm
- FIRE ALARM SYSTEM**
- OPTICAL SMOKE
- CEILING MOUNTED SPEAKER

REFER TO ELECTRICAL & MECHANICAL DETAIL DRAWINGS FOR FULL SPECIFICATIONS. THESE ARE SHOWN FOR CO-ORDINATION PURPOSE ONLY (ie. LOCATIONS OF ALL FITTINGS)

- LEGEND: LIGHTING**
- EXISTING MODULAR LUMINAIRE
 - RELOCATED MODULAR LUMINAIRE
 - RELOCATED EMERGENCY MODULAR LUMINAIRE
 - NEW DOWNLIGHTER TO MATCH EXISTING PERIMETER LIGHT. DAL LED.
 - EXISTING PERIMETER LIGHT.
 - BB LIGHTING STAGG DAL DIMMABLE 15W 4000K LED 100x100mm SQUARE DOWNLIGHTER. PART No. STAGG.1810.4K.DAL.
 - BB LIGHTING STAGG DAL DIMMABLE 15W 4000K LED 100x100mm SQUARE DOWNLIGHTER WITH 3 HR EMERGENCY PACK. PART No. STAGG.1810.4K.DALLEM.
 - BB LIGHTING MANTIS DAL DIMMABLE 15W LED 4000K 105mm DIA. DOWNLIGHTER. PRODUCT CODE: MAN-1430-DAL.
 - VISTOSI LUCCOLA SPM PENDANT LIGHT WITH 41cm DIA. GLASS SHADE AND E27 LAMP HOLDER. PRODUCT CODE: VS-LUCCOLASPM
 - SPECIALS LIGHTING DAL DIMMABLE 4000K LED 1985x58mm FLUSH THROUGH LIGHT WITH TRIM. PART No. SLSOR.1985.3.5B.840.DAL.
- LEGEND CONT'D:**
- EXISTING RECESSED LUMINAIRE RELOCATED WHERE NECESSARY TO SUIT NEW SPACE PLAN. LED TAPE
 - BB LIGHTING 3W NON MAINTAINED STAND ALONE EMERGENCY DOWNLIGHT ECLIPSE OA. PART No. ECP/04/210/MM.
 - EXISTING PIR OCCUPANCY SENSOR LIGHT SWITCH
 - RELOCATED PIR OCCUPANCY SENSOR LIGHT SWITCH
 - NEW PIR OCCUPANCY SENSOR LIGHT SWITCH
 - SCENE SET DIMMING CONTROL SWITCH
 - INDICATES RELOCATED ITEM.
 - SPRINKLERS
 - NEW CEILING PENDANT SPRINKLER HEAD
 - EXISTING CEILING PENDANT SPRINKLER HEAD
 - RELOCATED CEILING PENDANT SPRINKLER HEAD

REFER TO ELECTRICAL & MECHANICAL DETAIL DRAWINGS FOR FULL SPECIFICATIONS. THESE ARE SHOWN FOR CO-ORDINATION PURPOSE ONLY (ie. LOCATIONS OF ALL FITTINGS)

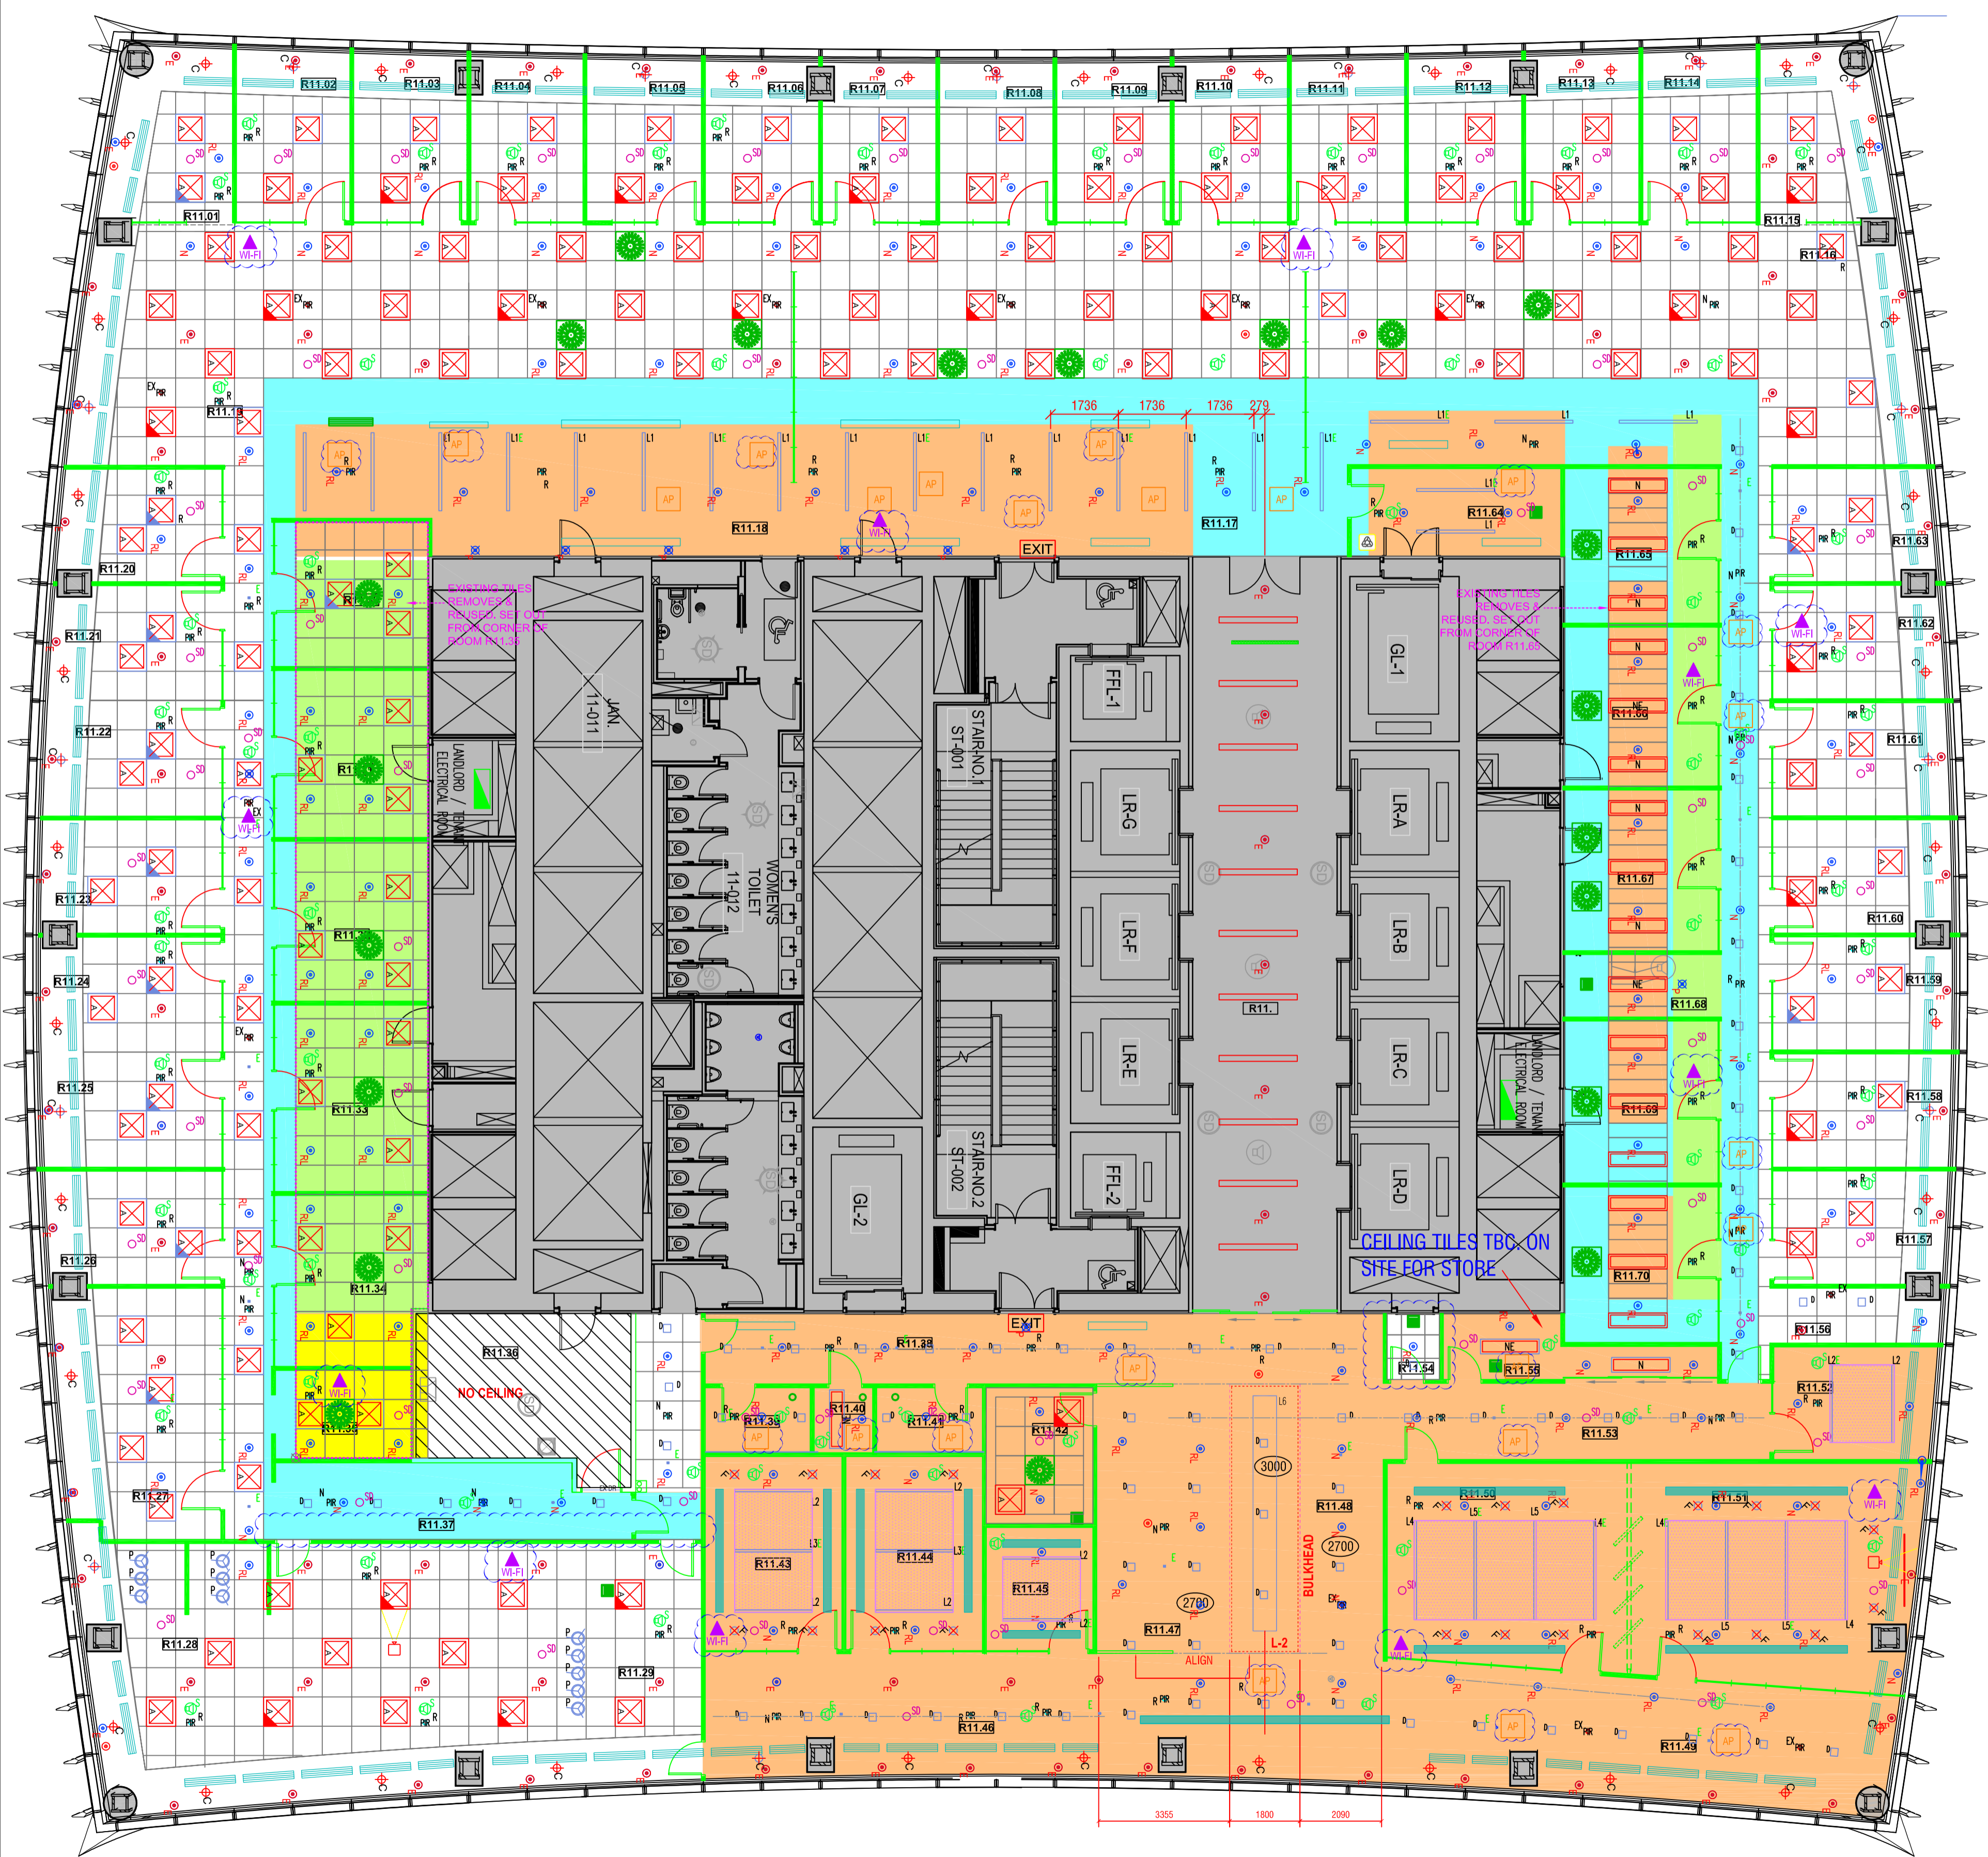

11TH FLOOR PLAN



This drawing is protected under Copyright and at no time must any portion of this drawing be reproduced or copied in anyway without the permission of Morgan Lovell.
All dimensions must be checked on site and NOT scaled from this drawing.

SUBJECT TO SITE SURVEY
CHECK SURVEY UNDERTAKEN ONLY
BUILDING PARAMETERS TAKEN FROM DRAWINGS PROVIDED
BUILDING PARAMETERS TAKEN FROM AS BUILT DRAWINGS PROVIDED

Rev	Revision	By	Date
H	WiFi ADDED. FIRE/SMOKE ACCESS HATCHES ADDED	VM	05.07.18
G	GRILLES REMOVED 750x750mm	VM	21.06.18
F	DESIGN DEVELOPMENT	VM	07.06.18
E	DESIGN DEVELOPMENT	VM	25.05.18
D	SPRINKLERS ADDED	VM	15.05.18
C	MECHANICAL & ELECTRICAL ADDED	VM	10.05.18
B	SPRINKLERS ADDED	VM	18.04.18
A	UPDATED TO LATEST LAYOUT	VM	23.02.18
-	FIRST ISSUE	VM	16.01.18

CONSTRUCTION

Morgan Lovell

16 Noel Street London W1F 8DA
T: 0207 734 4466 F: 0207 734 2968 E: contact@morganlovell.com
W: http://www.morganlovell.com

KING & WOOD MALLESONS

Client
Project
20 FENCHURCH STREET
LONDON

**11TH FLOOR
PROPOSED RCP**

Scale	Date	Designer/Drawn By	Checked By / Date
1:100@A1	16.01.2018	KL/ VM	KL

Drawing Number			
Project No.	Floor	Drawing No.	Rev
ML2780	11	200	H